

211 Worcester Providence Turnpike - Concierge Physical Therapy

Town of Sutton, MA


1 inch = 125 Feet

October 13, 2023



www.cai-tech.com

MAP 18 PARCEL 63

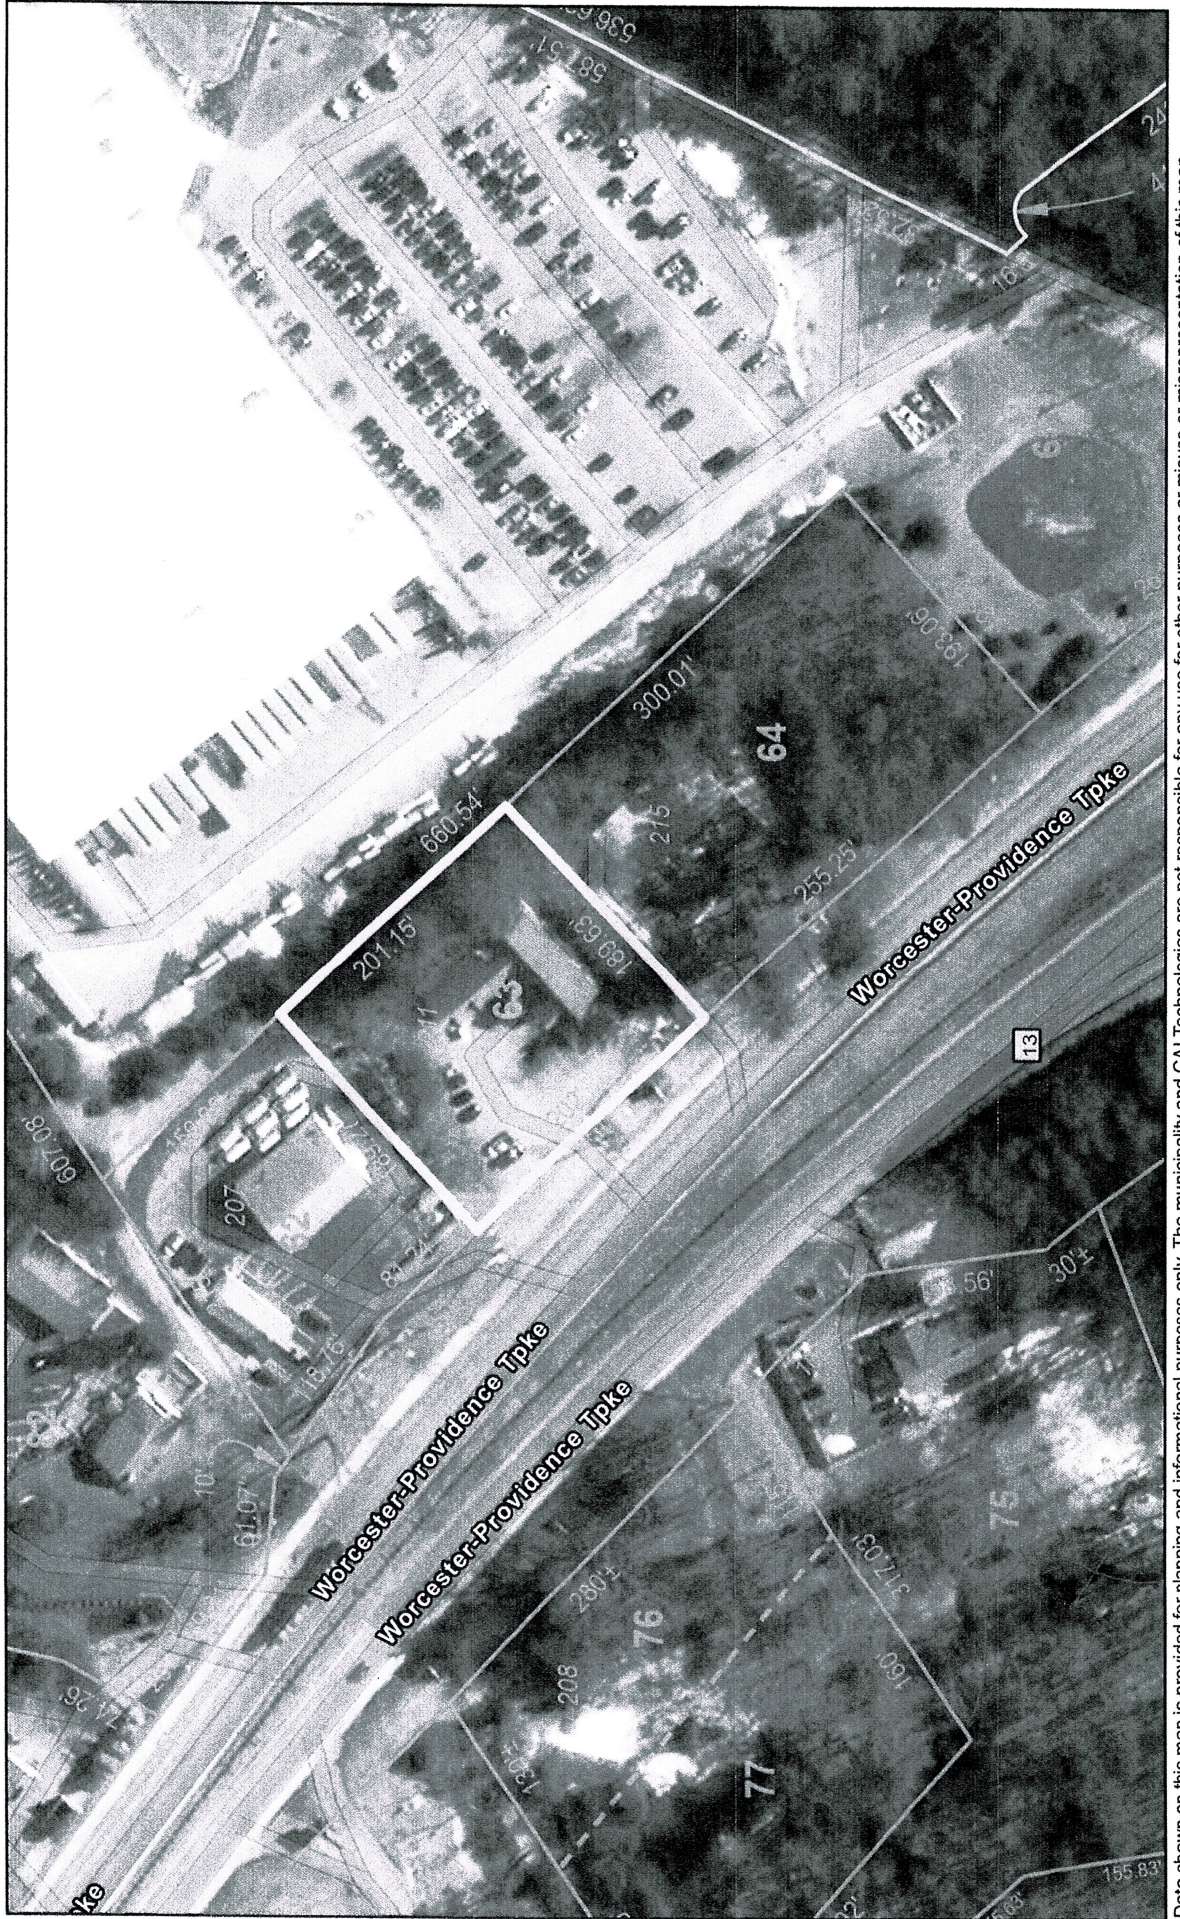

Data shown on this map is provided for planning and informational purposes only. The municipality and CAI Technologies are not responsible for any use for other purposes or misuse or misrepresentation of this map.

SFA

STEPHEN F LESHMAN
A ARCHITECT, LLC
 99 APPLE ROAD
 BRIMFIELD, MA 01010
 T: 508.347.7188 F: 508.347.8939

CONCIERGE PT
 211 WORCESTER - PROVIDENCE TURNPIKE
 SUTTON, MASSACHUSETTS

DEMOLITION PLANS


ACTION	DATE	BY	DESCRIPTION
A	01/23	SLF	CLINT CORRECTIONS
B	01/23	SLF	FOR FIRST

23-044

SCALE: 1"=10'-0"

AS NOTED SRF

DRAWING NO. **A1**

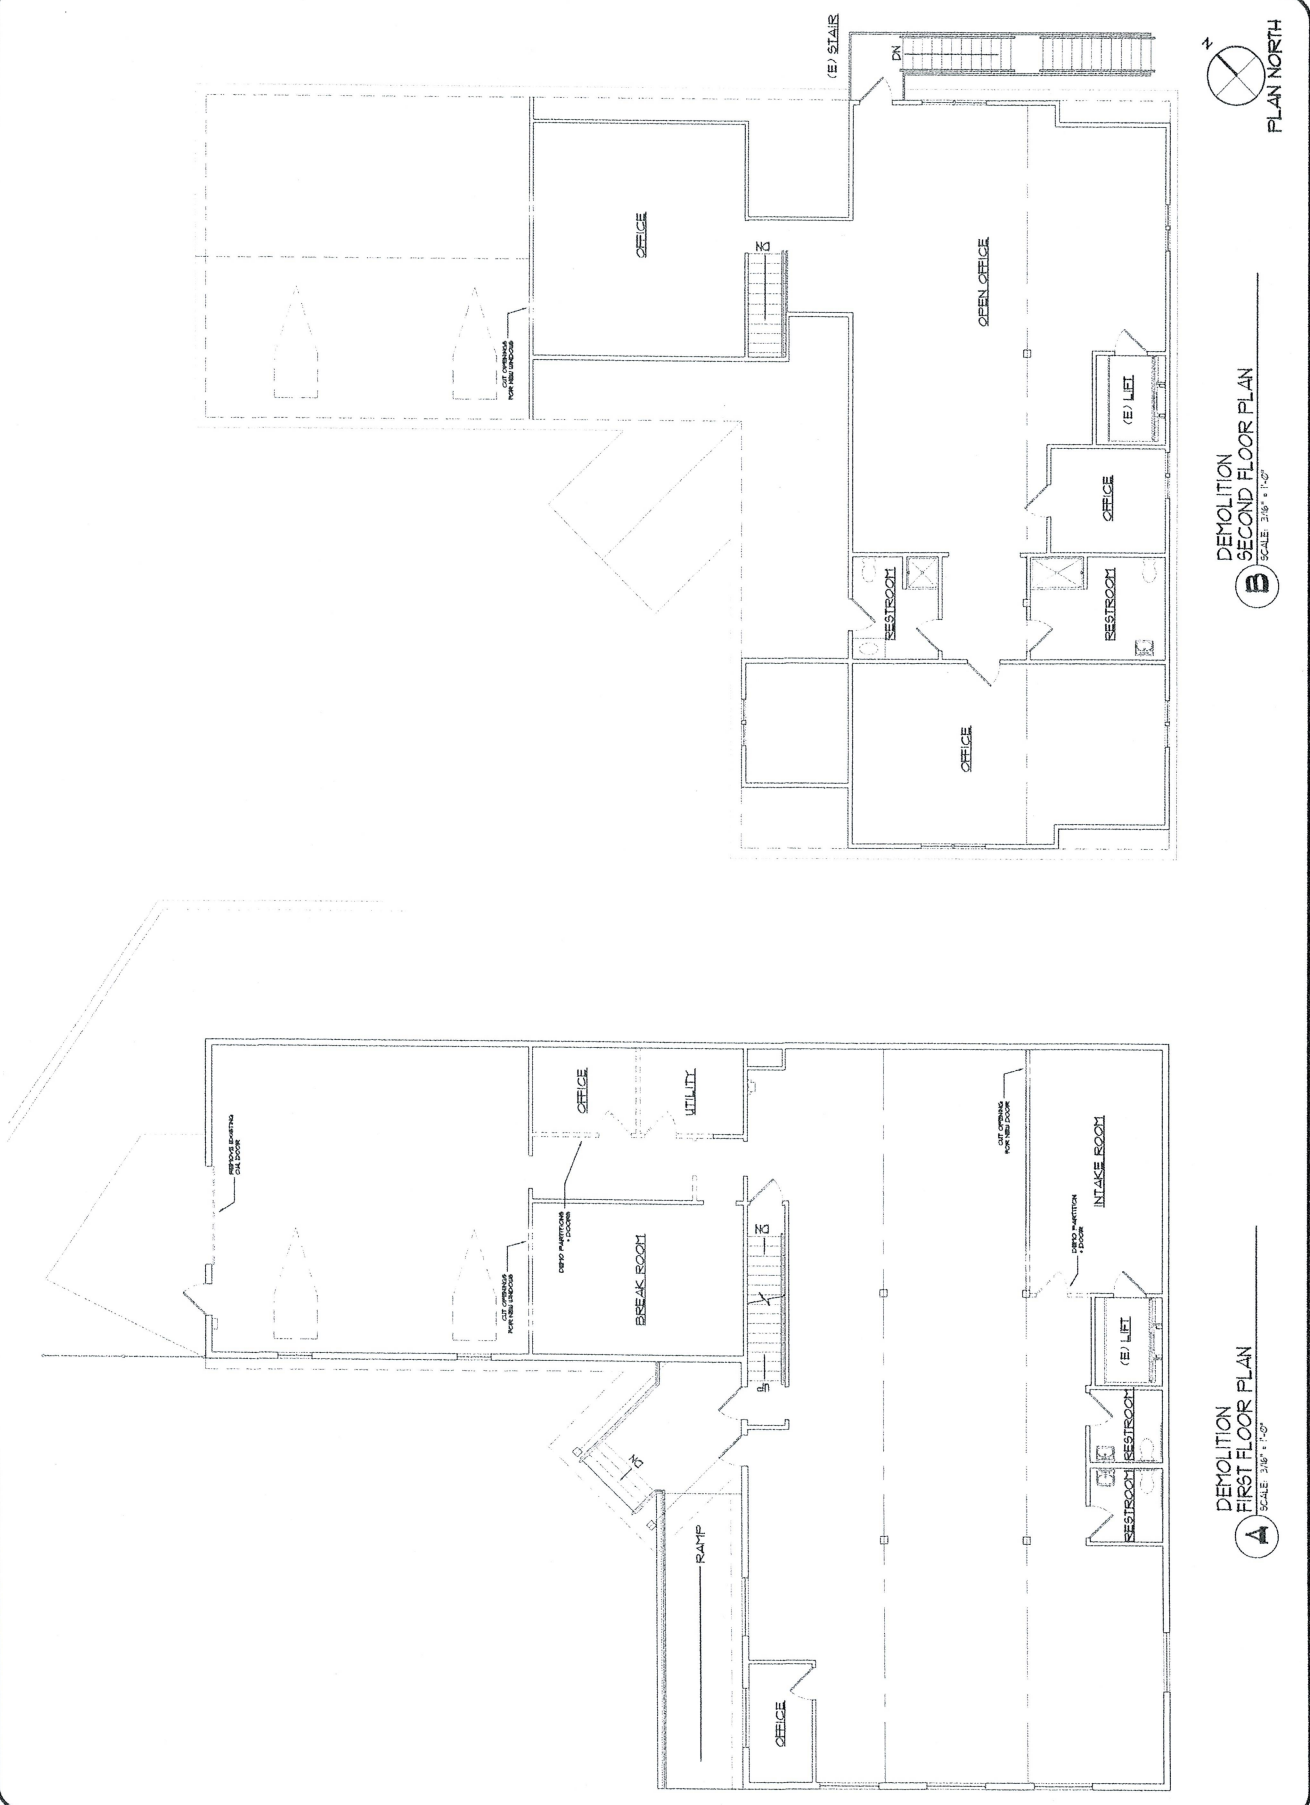

SFA

STEPHEN F LESHMAN
ARCHITECT, LLC
99 APPLE ROAD
BRIMFIELD, MA 01010
T: 508.347.7188 F: 508.347.8939

CONCIERGE PT
211 WORCESTER - PROVIDENCE TURNPIKE
SUTTON, MASSACHUSETTS
REFLECTED CEILING PLANS

ACTION		DATE	BY	DESCRIPTION
A	D			
		01/23/23	SR	CLASH COORDINATIONS
		02/22/23	SR	FOR REVISION



23-044
SCALE: DRAWN BY: SFL
AS NOTED: SFL
DRAWING NO. A3

CEILING LEGEND:

- A NEW ACOUSTICAL CEILING TYPE A
- B EXISTING EXPOSED STRUCTURE TO REMAIN

CEILING MANUFACTURES:


- A CELING TILE, ARISTON 2X4 CORONA 3/4"X9" ANGLED TESSILE TILE
- A CELING GRID, ARISTON PRIMER 4'X8' SUSPENSION SYSTEM

LEGEND

- EMERGENCY LIGHT
- EXIT SIGN
- EXIT SIGN W/ E LIGHT

REFLECTED CEILING PLAN SYMBOLS

- 2X4 FLUORESCENT LIGHT FIXTURE REFER TO ELEC PLANS FOR TYPE
- 2X2 FLUORESCENT LIGHT FIXTURE REFER TO ELEC PLANS FOR TYPE
- FLUORESCENT DROP - REFER TO ELEC. PLANS FOR LAYOUTS
- FLUORESCENT TRIM - REFER TO ELEC. PLANS FOR LAYOUTS
- RECESSED LIGHT FIXTURE
- PENDANT CEILING FIXTURE
- BALL SCENE
- CEILING SUPPLY AIR DIFFUSER
- CEILING RETURN AIR GRILLE
- ACCESS PANEL
- NEW ACOUSTICAL TILE CEILING
- EXISTING SPRINKLER HEAD

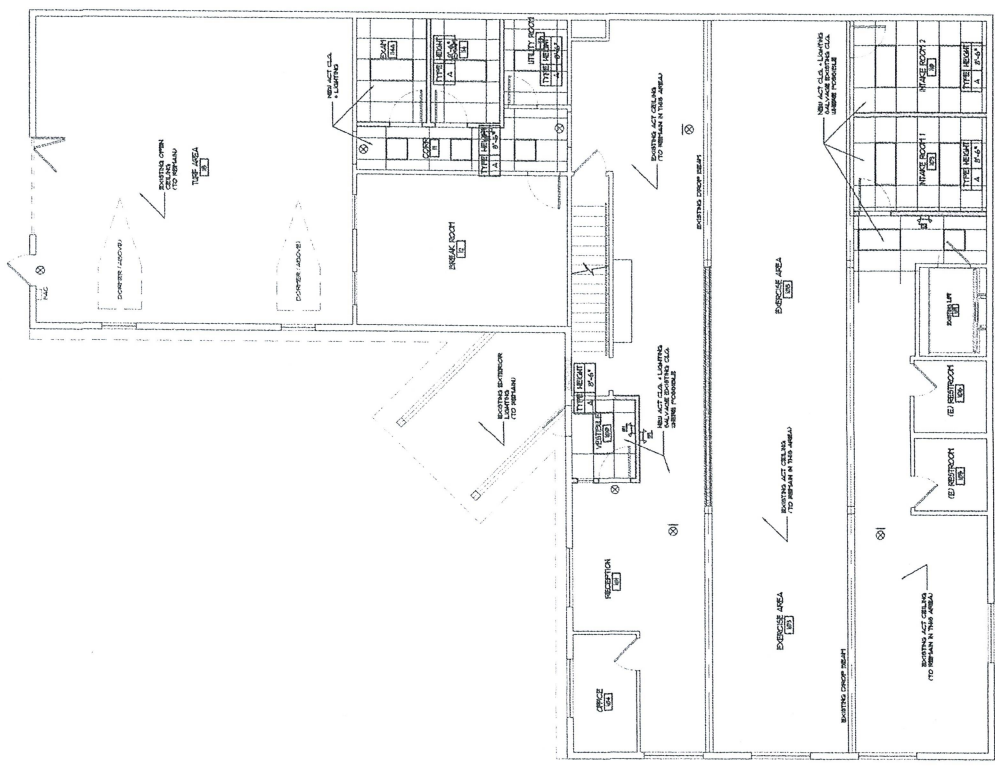

PROPOSED
FIRST FLOOR RCP
SCALE: 3/8" = 1'-0"

PROPOSED
SECOND FLOOR RCP
SCALE: 3/8" = 1'-0"



SFA

STEPHEN F. LESHMAN
ARCHITECT, LLC
99 APPLE ROAD
BRIMFIELD, MA 01010
T: 508.347.7188 F: 508.347.8939

CONCIERGE PT
211 WORCESTER - PROVIDENCE TURNPIKE
SUTTON, MASSACHUSETTS
INTERIOR ELEVATIONS/DETAILS


DATE	DESCRIPTION	ACTION
01/23/21	REV. 1	
01/23/21	CLASH CORRECTIONS	




23-044
SCALE: DRAWN BY:
AS NOTED SFL

DRAWING NO.

A4

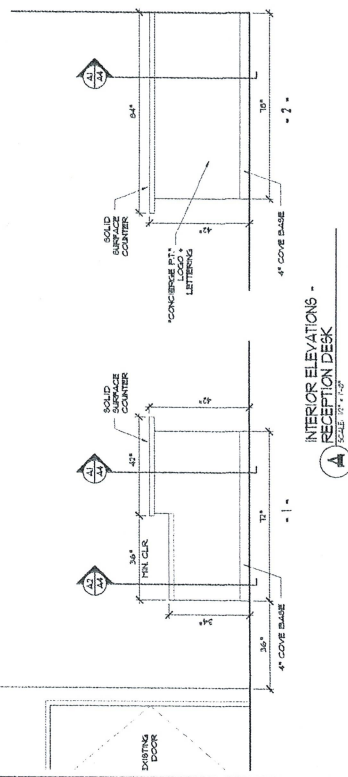


INTERIOR ELEVATIONS -
RECEPTION DESK
SCALE 1/4\"/>

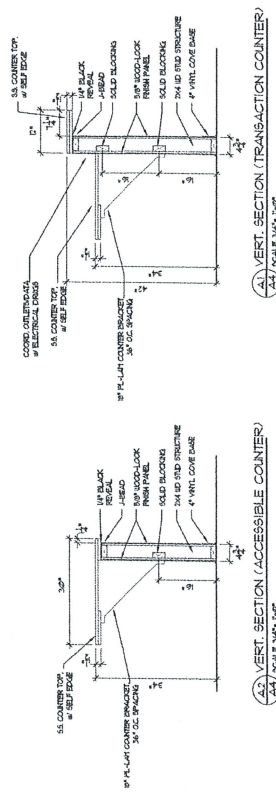


VERT. SECTION (TRANSACTION COUNTER)
SCALE 3/4\"/>


VERT. SECTION (ACCESSIBLE COUNTER)
SCALE 3/4\"/>

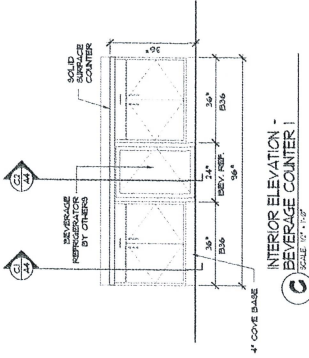


INTERIOR ELEVATION -
BEVERAGE COUNTER 1
SCALE 1/4\"/>

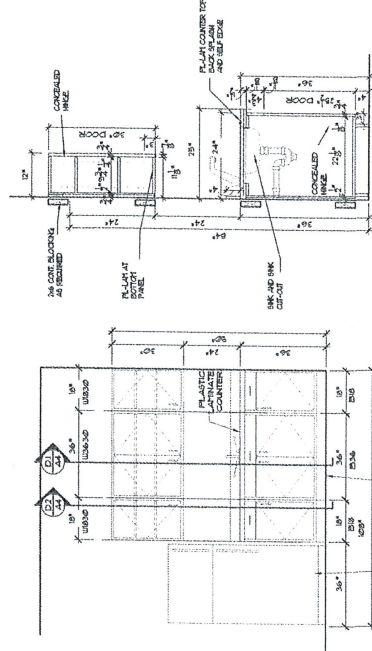

INTERIOR ELEVATION -
BREAK ROOM MILLWORK
SCALE 1/4\"/>

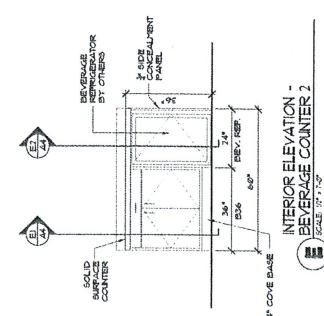


INTERIOR ELEVATION -
BEVERAGE COUNTER 2
SCALE 1/4\"/>

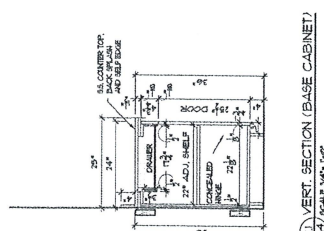

VERT. SECTION (BASE CABINET)
SCALE 3/4\"/>

VERT. SECTION (BASE 4 WALL CABINET)
SCALE 3/4\"/>

VERT. SECTION (BASE 1 WALL CABINET)
SCALE 3/4\"/>

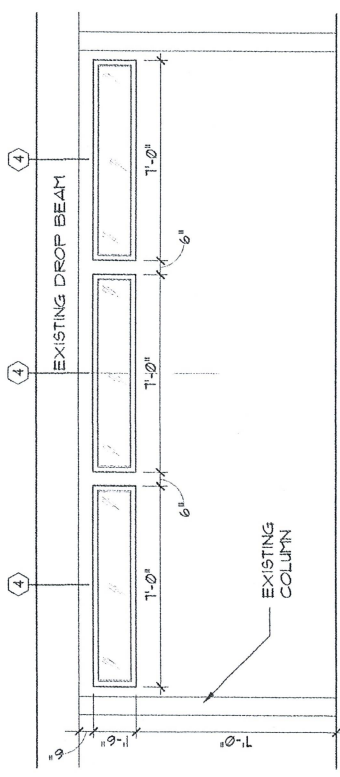

INTERIOR ELEVATION -
WAITING AREA DIVIDER
SCALE 1/4\"/>

